


Paladin & Associates

SKYLAR GREENBERG

IND2461 BUILDING SYSTEMS


SUMMER 2023

SHEET LIST	
A-1	WORKCAFE FLOOR PLAN
A-2	CONFERENCE ROOM FLOOR PLAN
A-3	WORKCAFE POWER PLAN
A-4	WORKCAFE REFLECTED CEILING PLAN
A-5	CONFERENCE ROOM REFLECTED CEILING PLAN

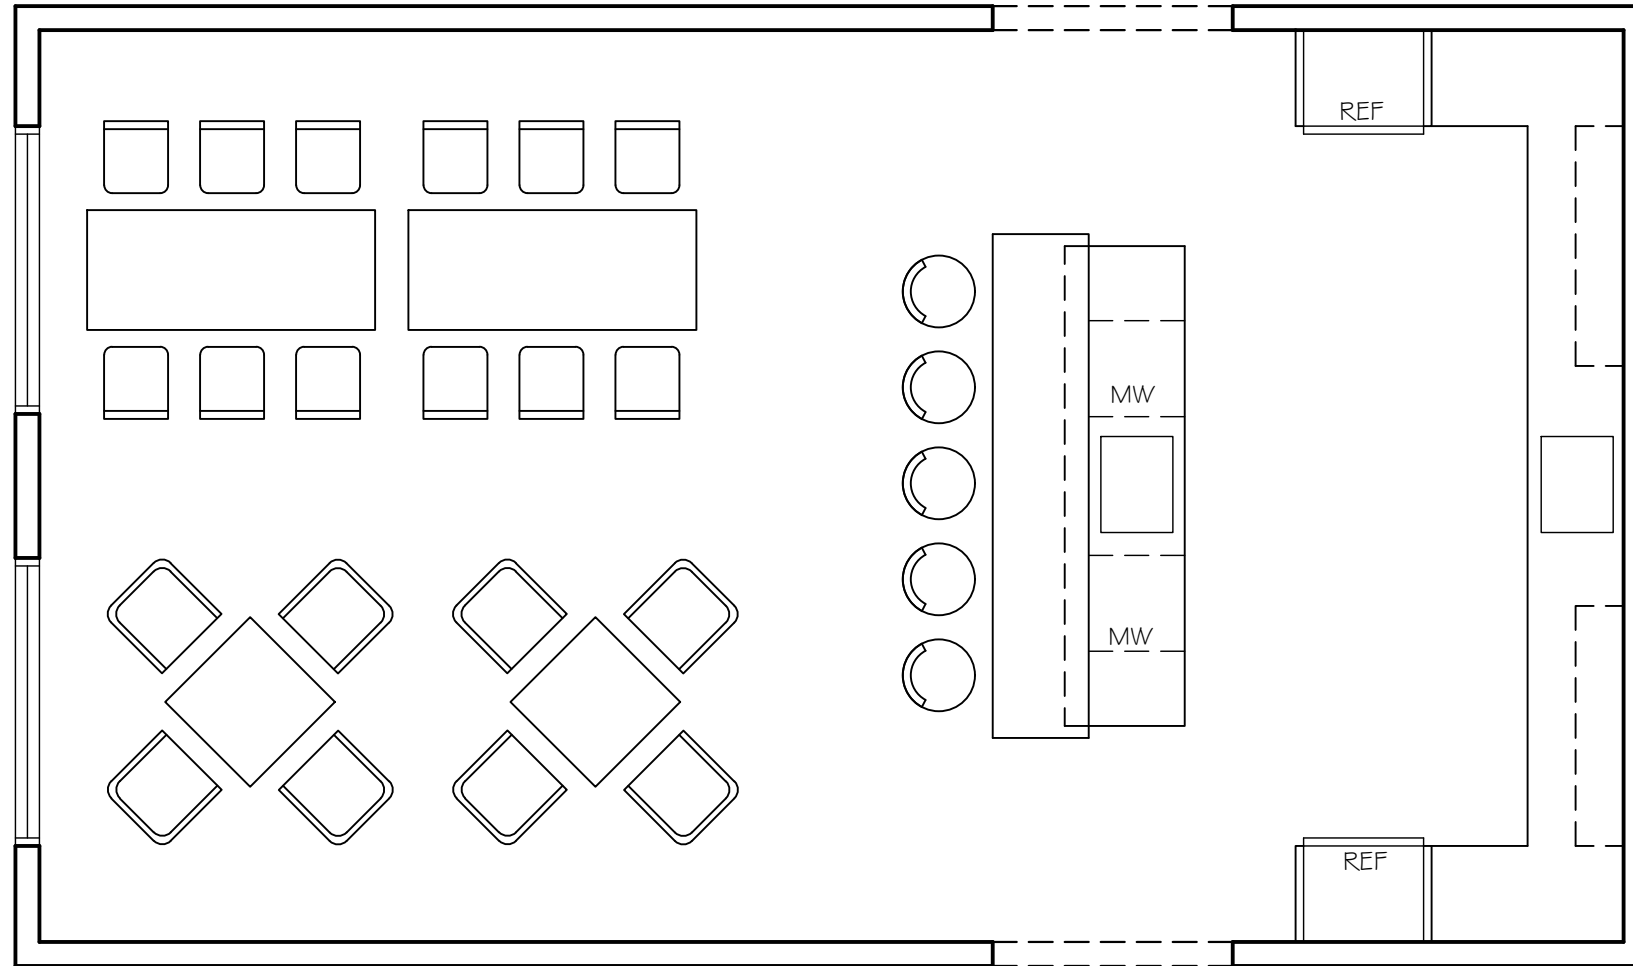

WORKCAFE FLOOR PLAN



1/4" = 1'-0"

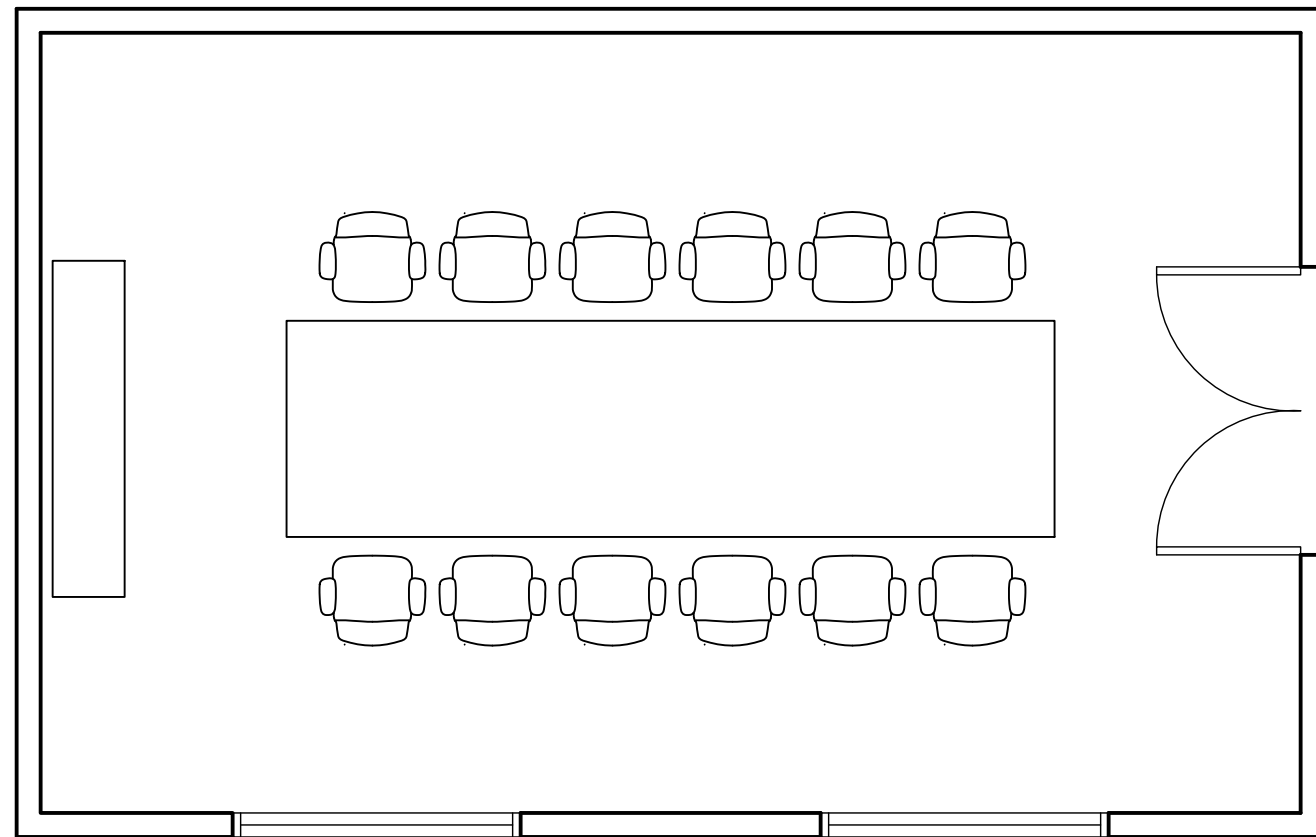

CONFERENCE ROOM FLOOR PLAN


1/4" = 1'-0"

PROJECT TITLE	PALADIN & ASSOCIATES	DRAWING TITLE	CONFERENCE ROOM FLOOR PLAN	SCALE	AS NOTED	DATE	7/2/23	SHEET NO.	A-2
				STUDENT NAME	SKYLAR GREENBERG				

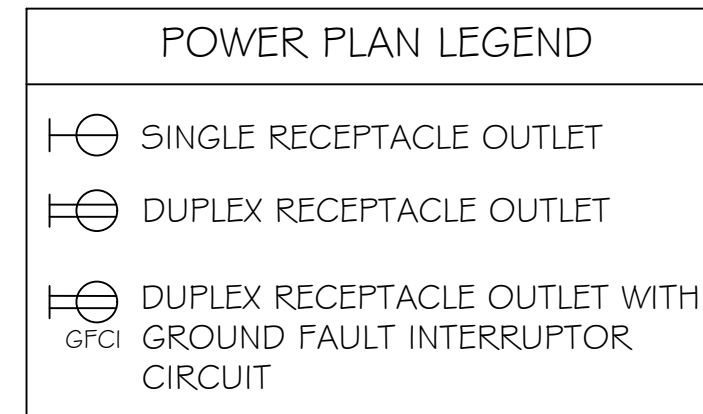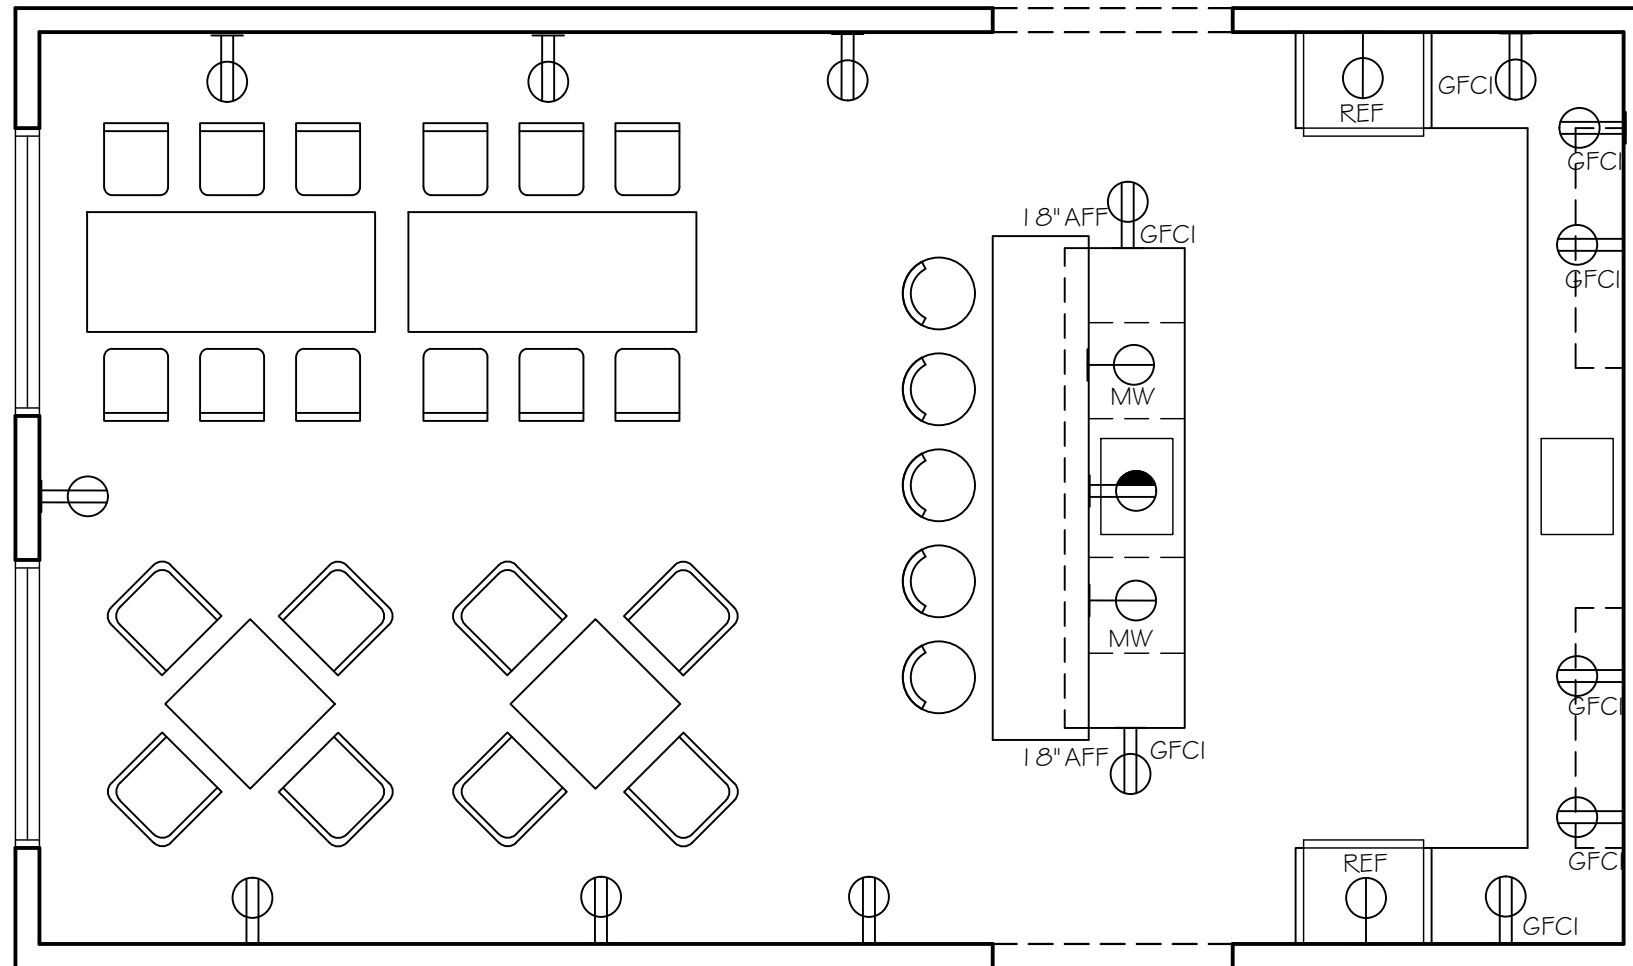

WORKCAFE POWER PLAN


1/4" = 1'-0"

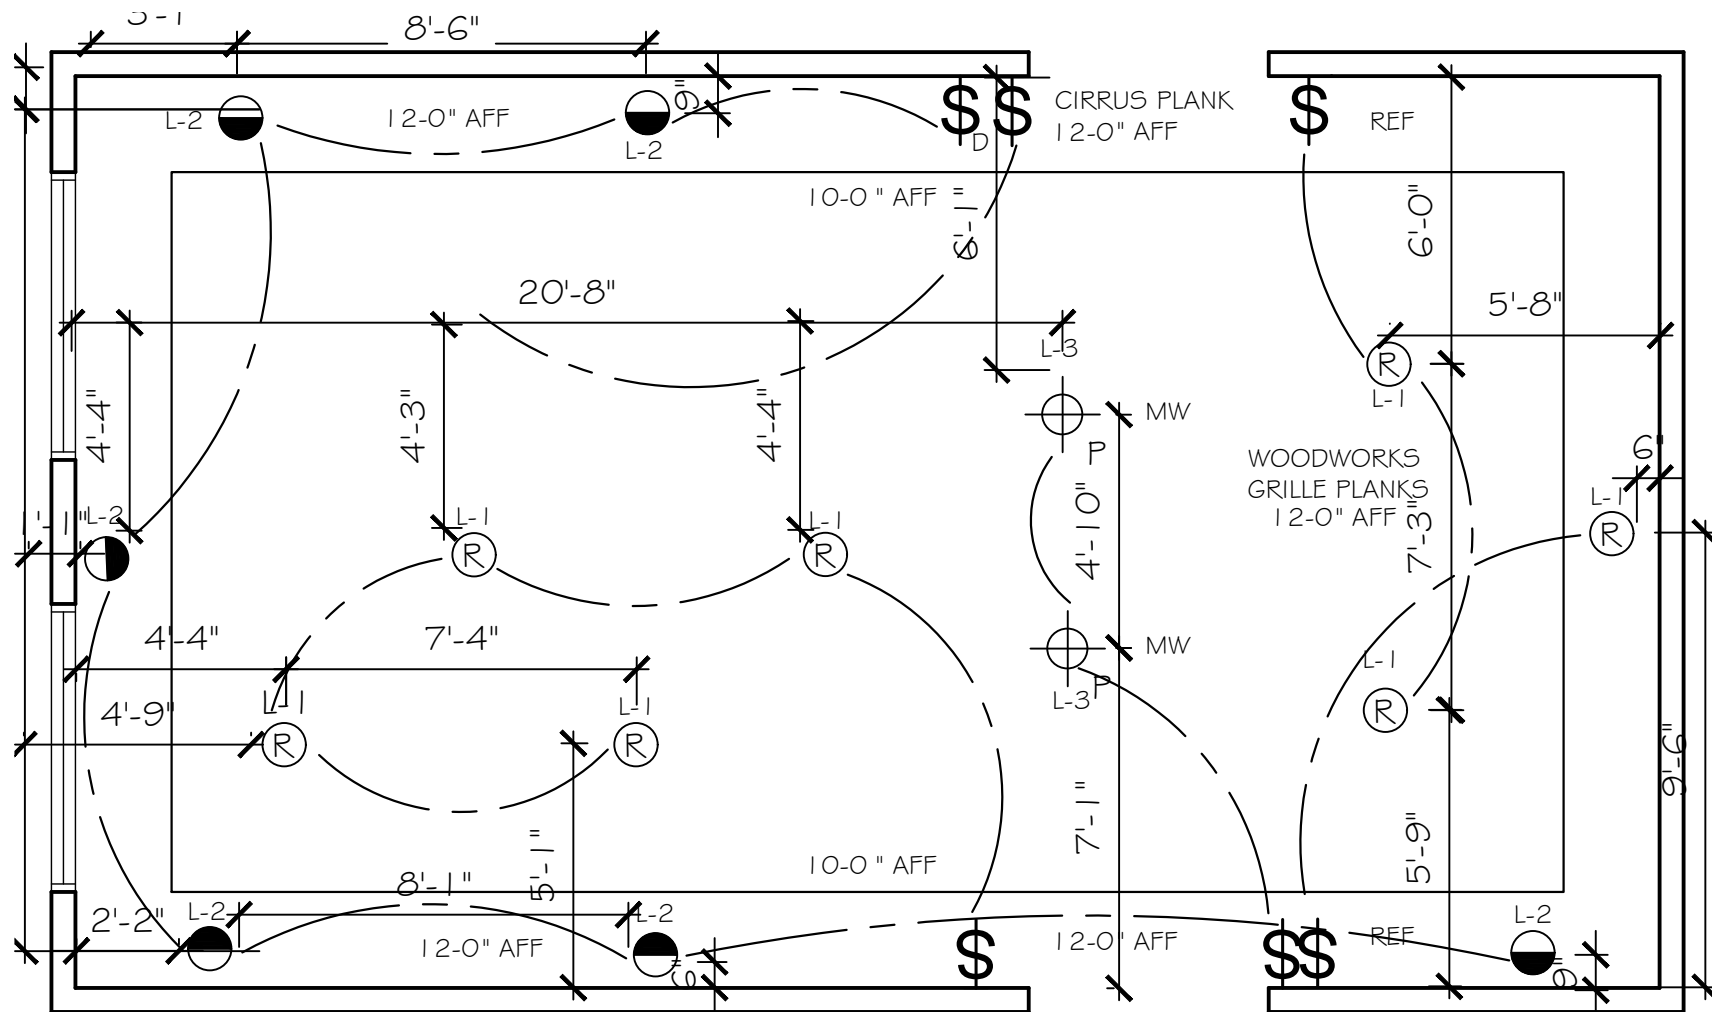

REFLECTED CEILING PLAN LEGEND	
	RECESSED WALL WASHER LIGHT FIXTURE
	RECESSED LIGHT FIXTURE
	CEILING MOUNTED PENDANT LIGHT FIXTURE
	SINGLE POLE SWITCH
	SWITCH WITH DIMMER
	FOUR-WAY SWITCH

WORKCAFE REFLECTED CEILING PLAN

1/4" = 1'-0"

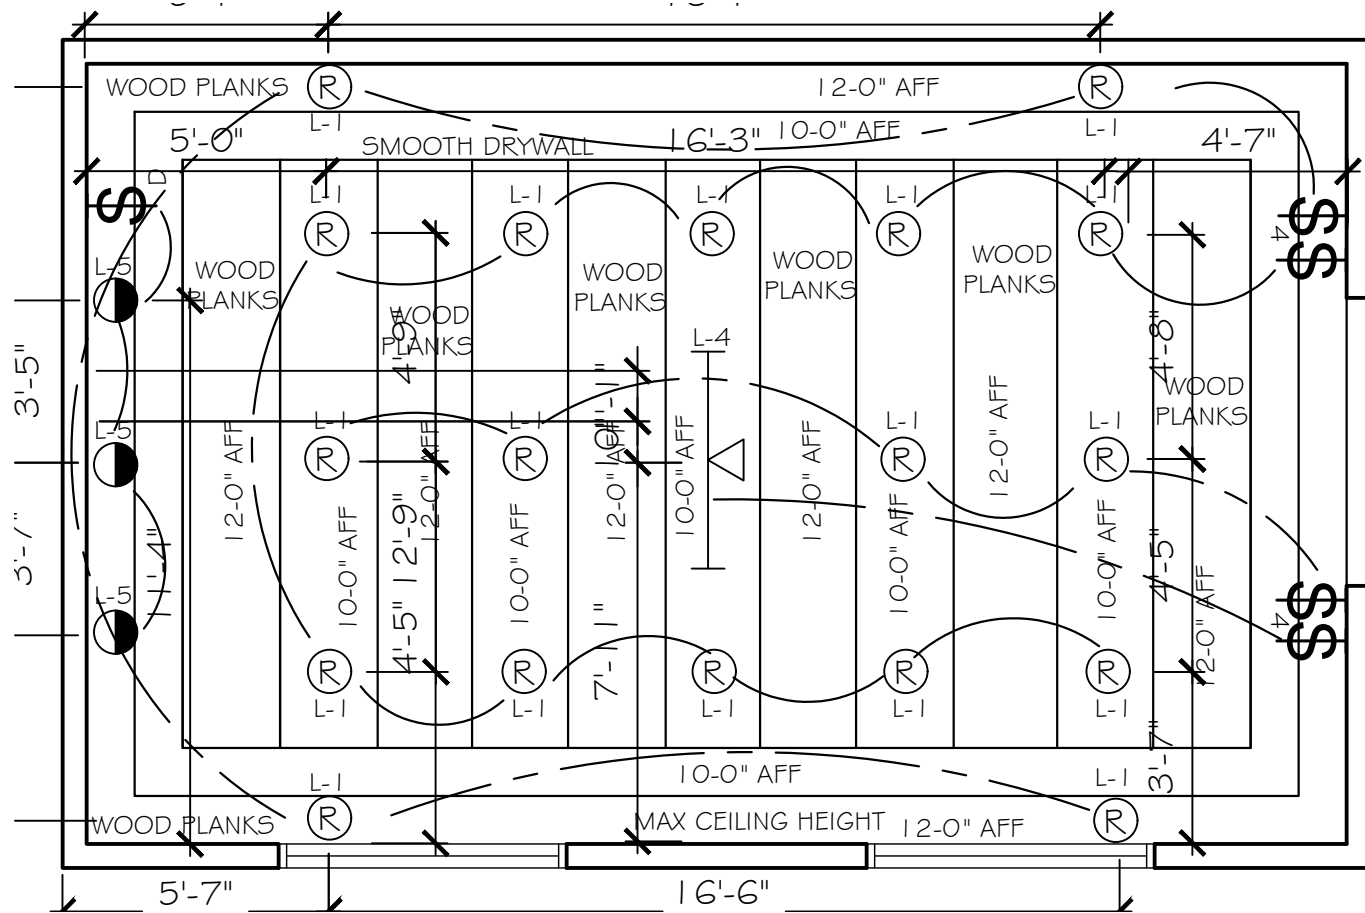

CONFERENCE ROOM REFLECTED CEILING PLAN

1/4" = 1'-0"

REFLECTED CEILING PLAN LEGEND	
	RECESSED WALL WASHER LIGHT FIXTURE
	RECESSED LIGHT FIXTURE
	TRACK LIGHTING
	SINGLE POLE SWITCH
	SWITCH WITH DIMMER
	FOUR-WAY SWITCH